

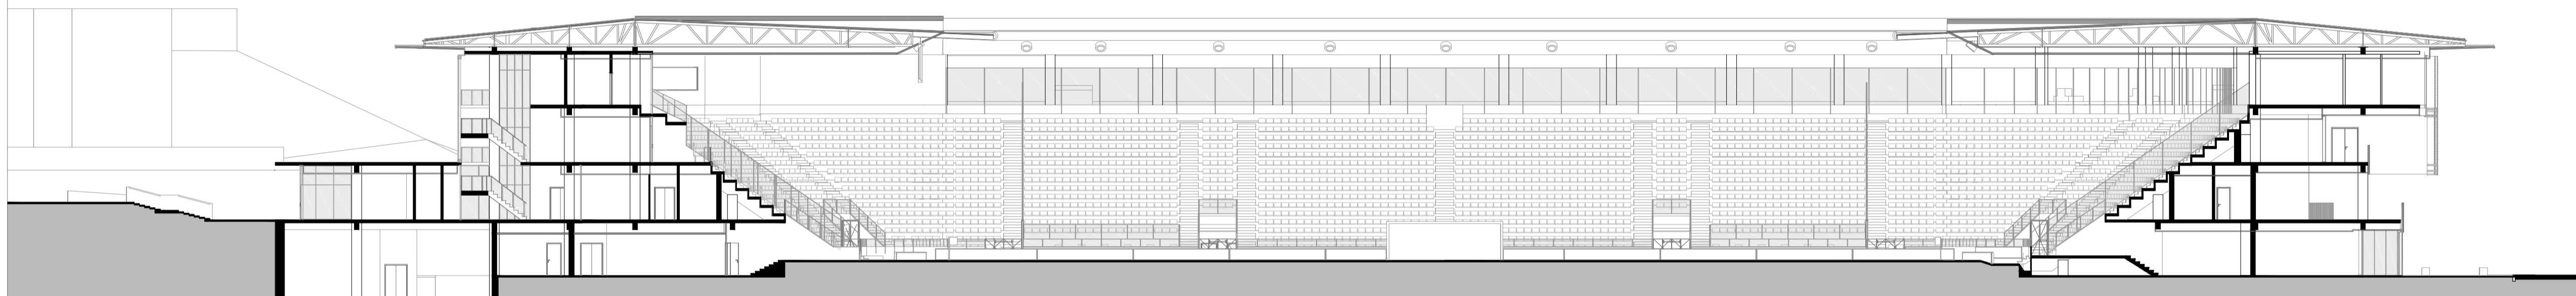



PIANTA PIANO TERRA Scala 1:500

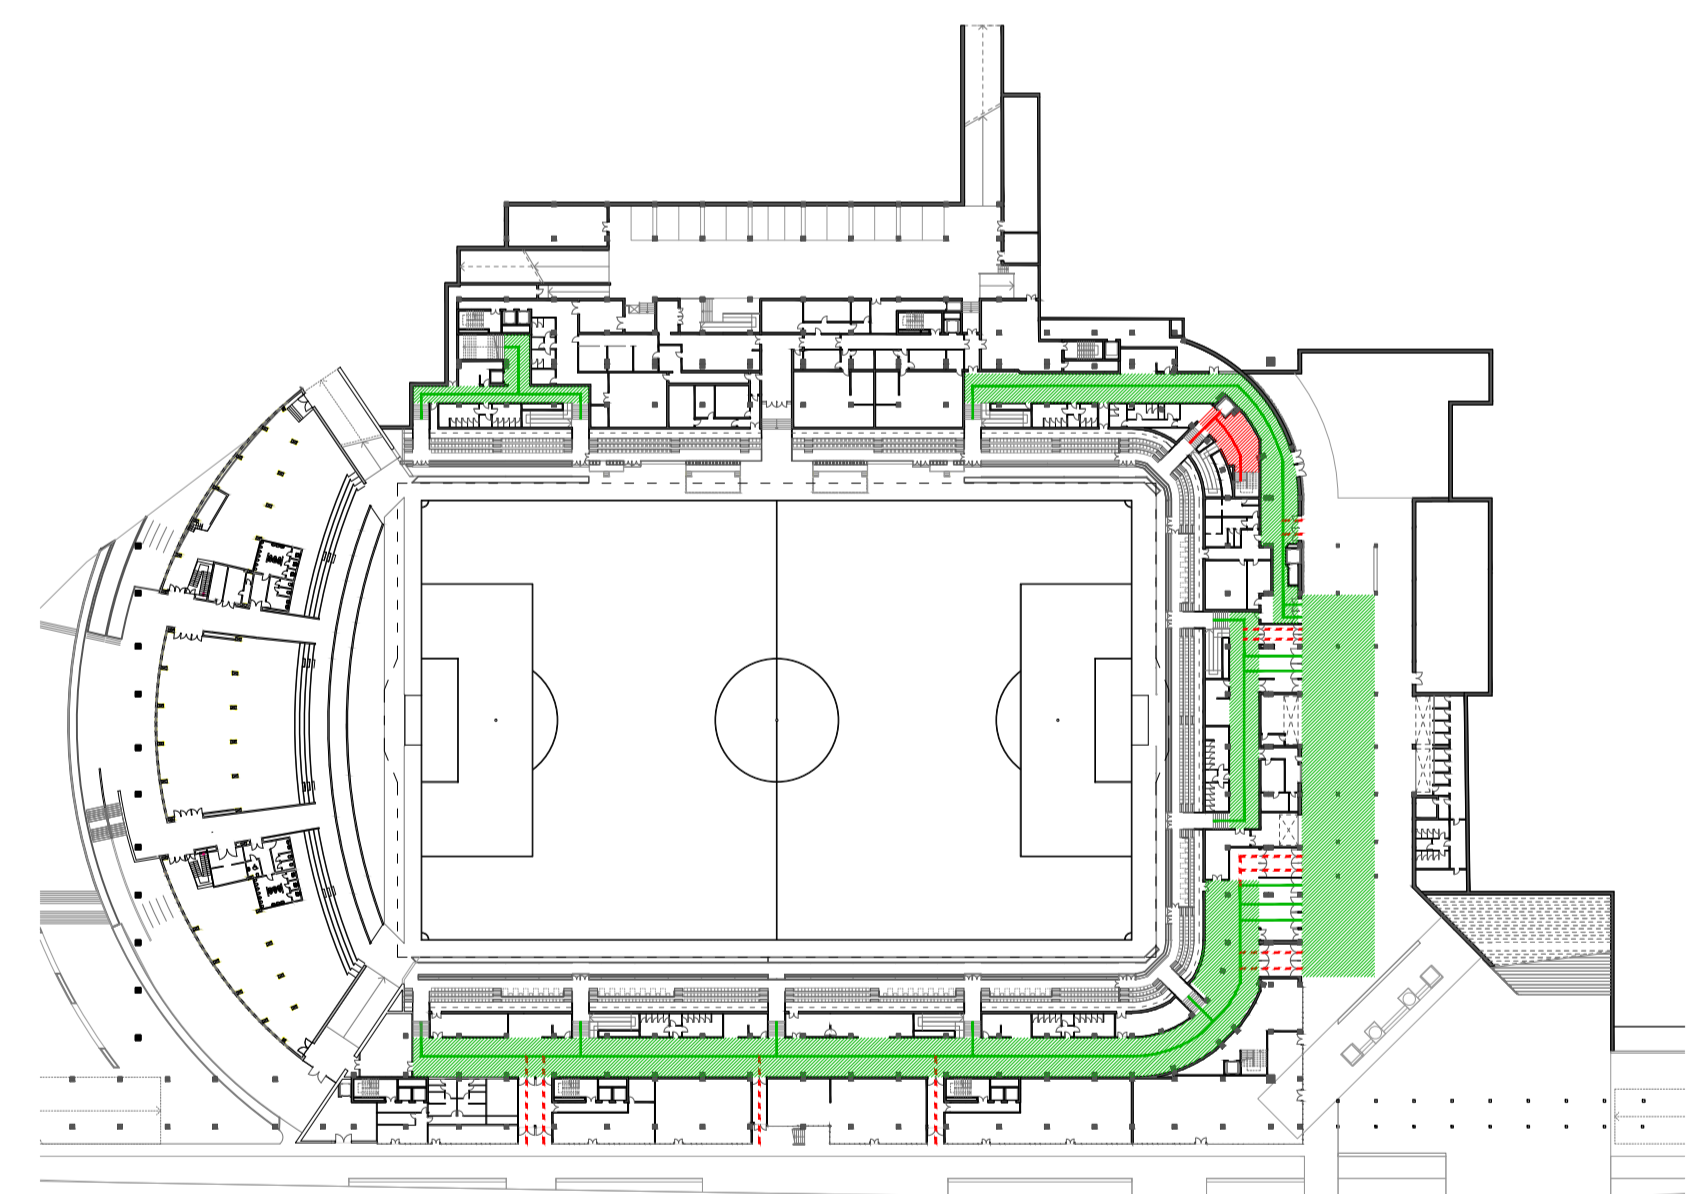

SEZIONE A - A Scala 1:250


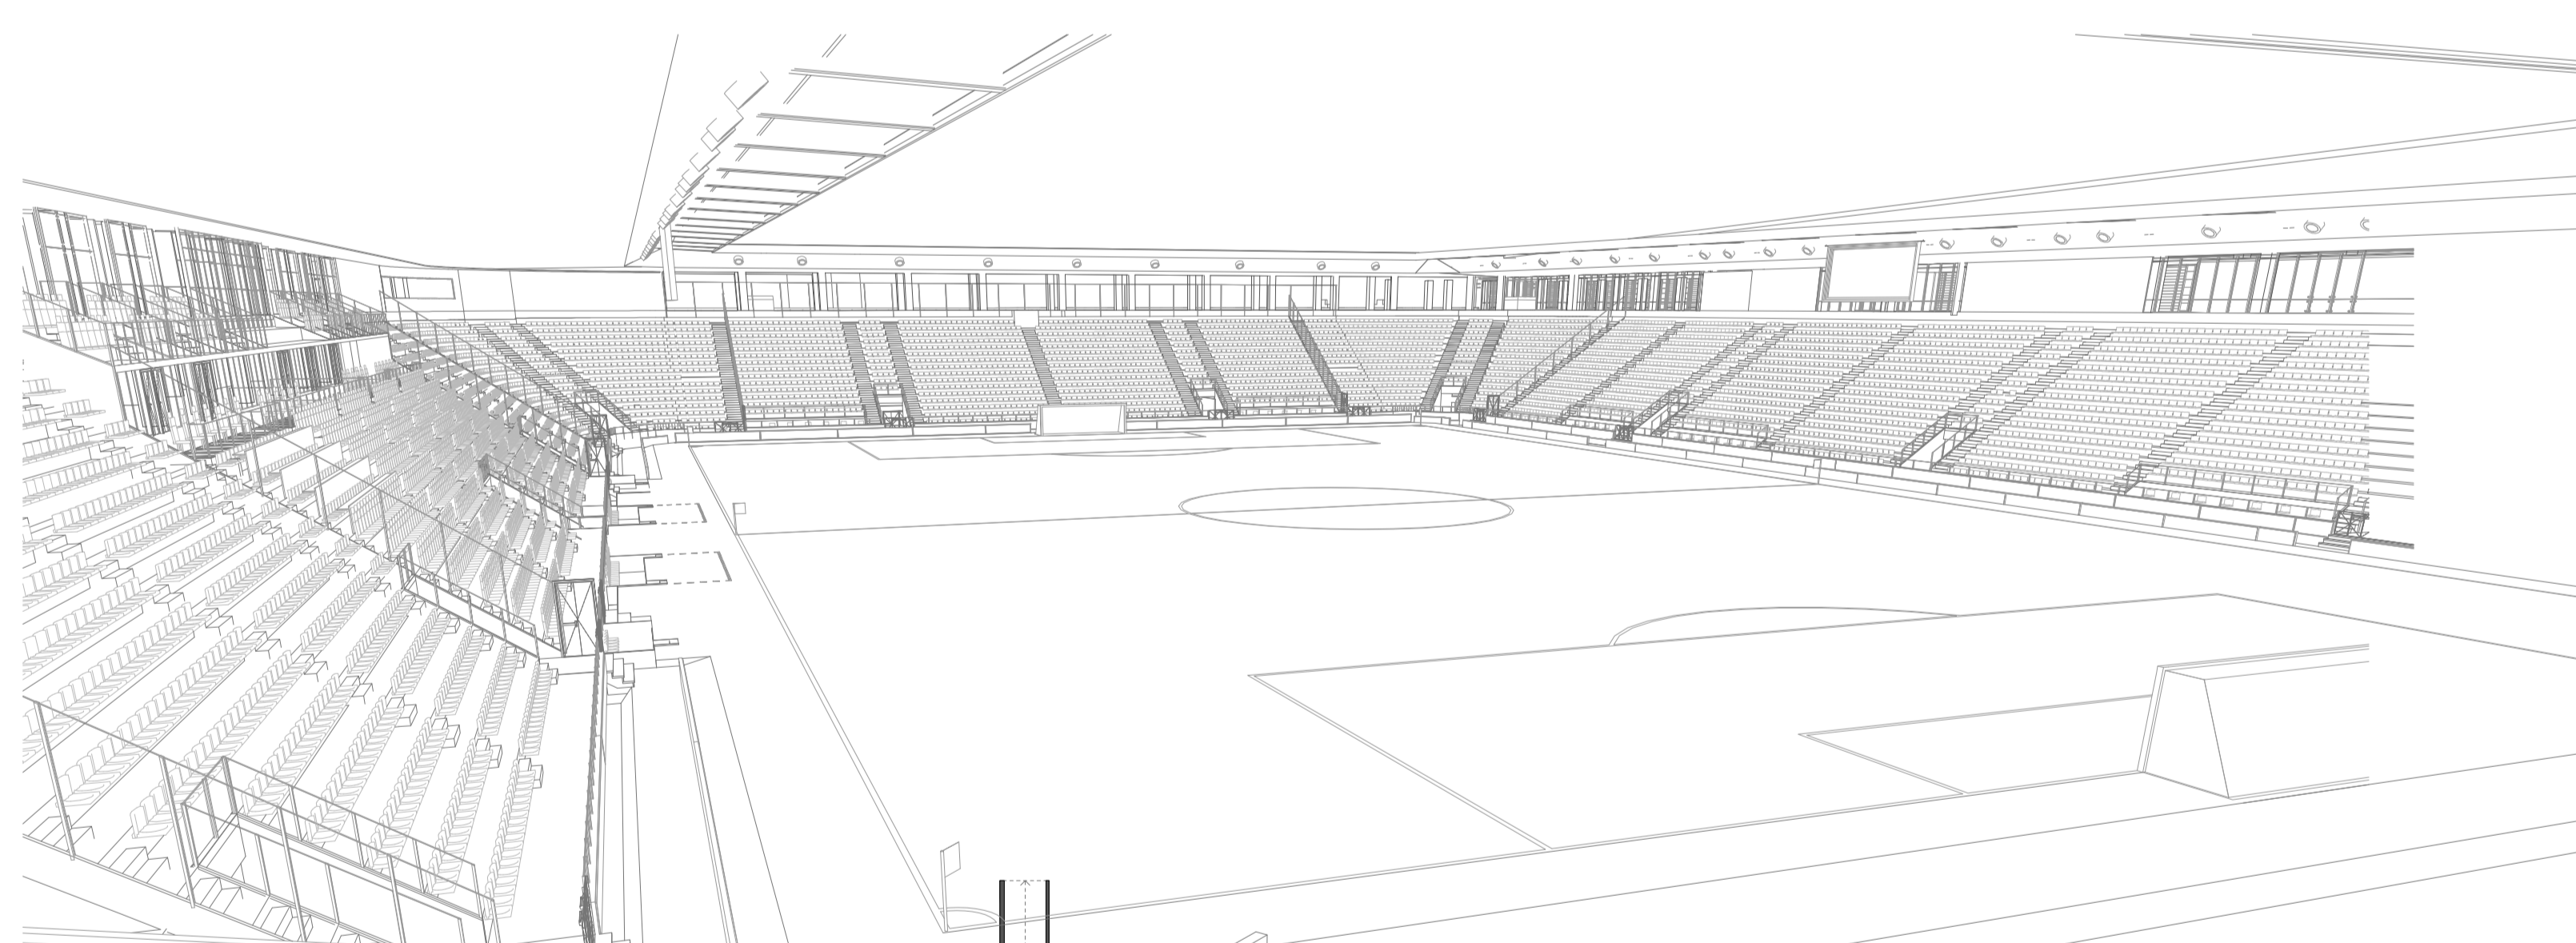


FLUSSI SPETTATORI E ACCESSI

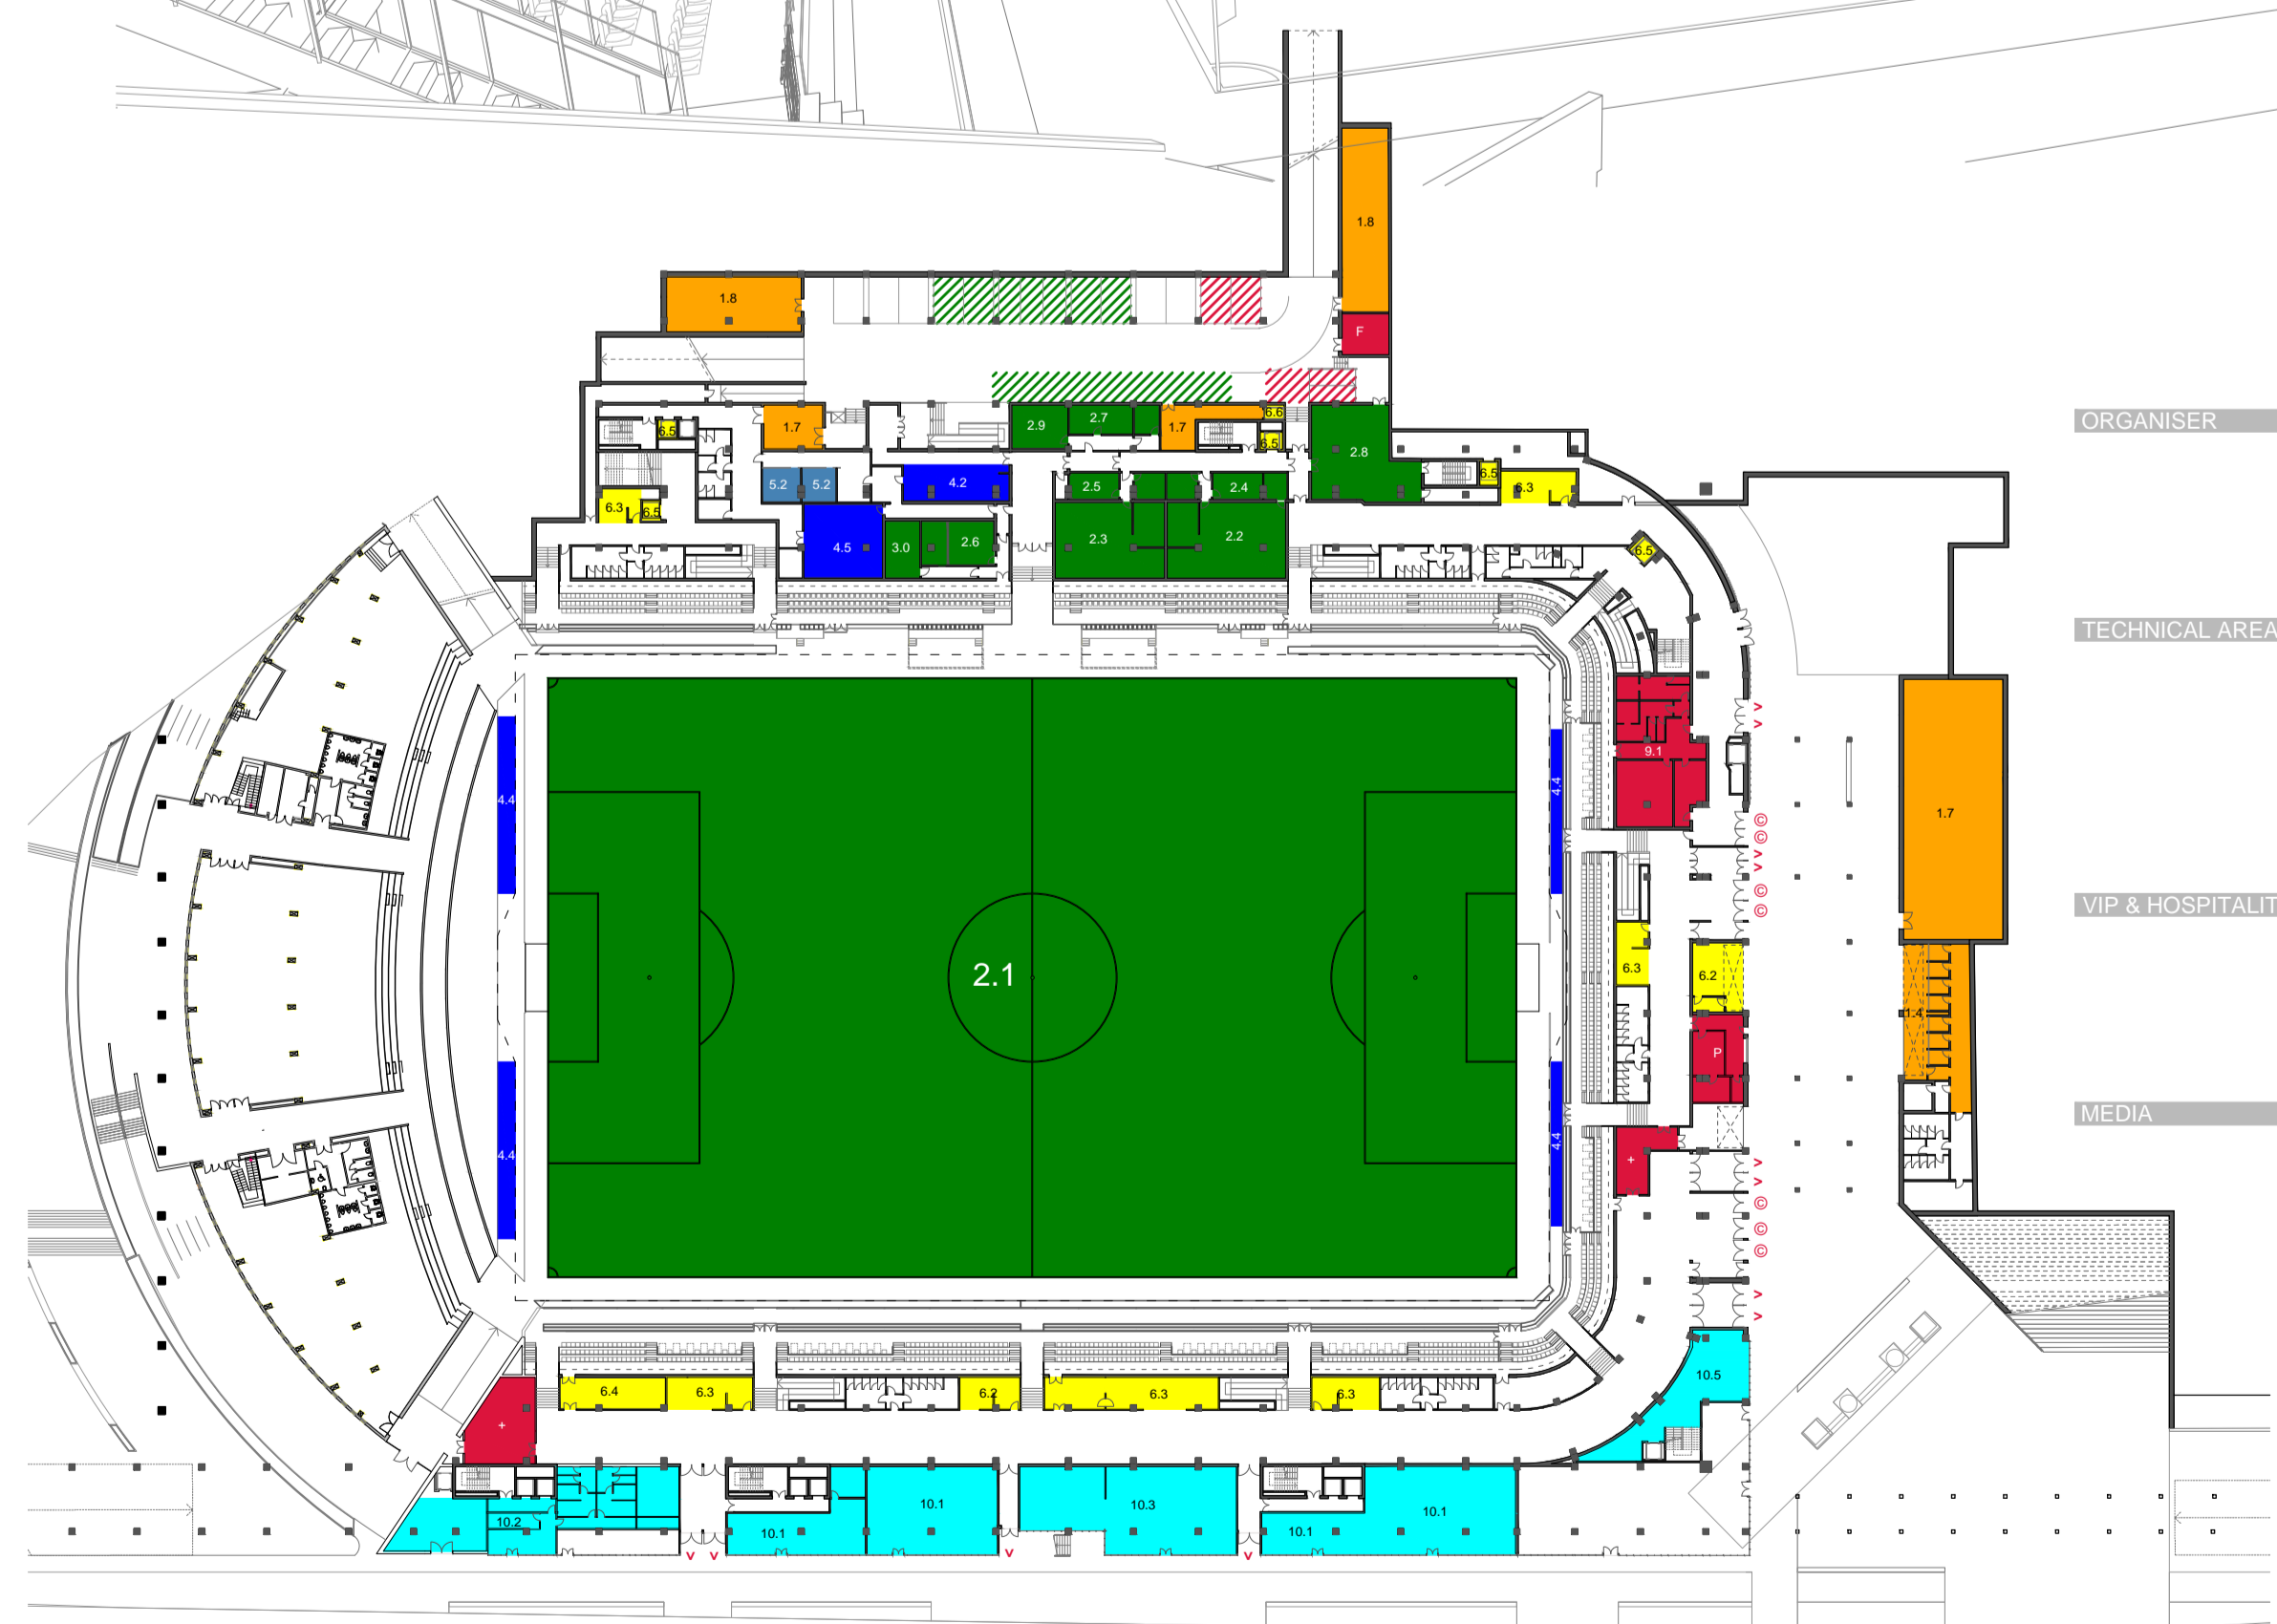

STADIUM LEVEL MAP - UEFA TEMPLATE

| ORGANISER | TECHNICAL AREA | VIP & HOSPITALITY | MEDIA | TV & STUDIO | SERVICE | SECURITY | PUBLIC SERVICES |
|----------------------------|-----------------------------|--------------------------|------------------------------|-----------------------------|-----------------------------|---------------------------|------------------------------------|
| 01 Office organiser | 21 Pitch | 31 VIP hospitality | 41 Stadium media centre | 51 Flash interview position | 61 Signage working area | 71 Steward centre | 81 Service commercial |
| 02 Accelerator centre | 22 Dressing room team A | 32 VIP tribune | 42 Media tribune | 52 Indoor TV studio | 62 Concession merchandising | 72 Stadium control room | 82 Service ristorazione e F&B |
| 03 Volunteer centre | 23 Dressing room team B | 33 Corporate hospitality | 43 Pitch view position | 53 Pitch view studio | 63 Concession F&B | 73 Security briefing area | 83 Service sport |
| 04 Ticket collection point | 24 Coaches room team A | 34 VIP area | 44 Press conference position | 54 Commentary position | 64 Waste management area | 74 Police | 84 Wholesale e retail universities |
| 05 Administration area | 25 Coaches room team B | 35 VIP tribuna | 45 Press conference room | 55 Camera position | 65 People lift | 75 Fire brigades | 85 Polo Turismo Liguria |
| 06 F&B | 26 Dressing room referees | 36 VIP tribuna | 46 Media hospitality | 56 TV production area | 66 People lift | 76 Fire brigades | 86 Auto / Baby Parking |
| 07 Storage organiser | 27 Emergency medical room | 37 VIP tribuna | 47 Press room | 57 TV compound / Parking TV | 67 Service lift | 77 Fire brigades | |
| 08 Technological area | 28 Emergency control office | 38 VIP tribuna | 48 Media hospitality | | | 78 Fire brigades | |
| | 29 Emergency medical room | 39 VIP tribuna | 49 Press room | | | 79 Fire brigades | |
| | 30 Staging control station | 40 VIP tribuna | 50 Press room | | | 80 Fire brigades | |
| | 31 Staging match operators | 41 VIP tribuna | 51 Press room | | | 81 Fire brigades | |
| | 32 Parking team & office | 42 VIP tribuna | 52 Press room | | | 82 Fire brigades | |
| | | 43 VIP tribuna | 53 Press room | | | 83 Fire brigades | |
| | | 44 VIP tribuna | 54 Press room | | | 84 Fire brigades | |
| | | 45 VIP tribuna | 55 Press room | | | 85 Fire brigades | |
| | | 46 VIP tribuna | 56 Press room | | | 86 Fire brigades | |
| | | 47 VIP tribuna | 57 Press room | | | 87 Fire brigades | |
| | | 48 VIP tribuna | 58 Press room | | | 88 Fire brigades | |
| | | 49 VIP tribuna | 59 Press room | | | 89 Fire brigades | |
| | | 50 VIP tribuna | 60 Press room | | | 90 Fire brigades | |
| | | 51 VIP tribuna | 61 Press room | | | 91 Fire brigades | |
| | | 52 VIP tribuna | 62 Press room | | | 92 Fire brigades | |
| | | 53 VIP tribuna | 63 Press room | | | 93 Fire brigades | |
| | | 54 VIP tribuna | 64 Press room | | | 94 Fire brigades | |
| | | 55 VIP tribuna | 65 Press room | | | 95 Fire brigades | |
| | | 56 VIP tribuna | 66 Press room | | | 96 Fire brigades | |
| | | 57 VIP tribuna | 67 Press room | | | 97 Fire brigades | |
| | | 58 VIP tribuna | 68 Press room | | | 98 Fire brigades | |
| | | 59 VIP tribuna | 69 Press room | | | 99 Fire brigades | |
| | | 60 VIP tribuna | 70 Press room | | | 100 Fire brigades | |

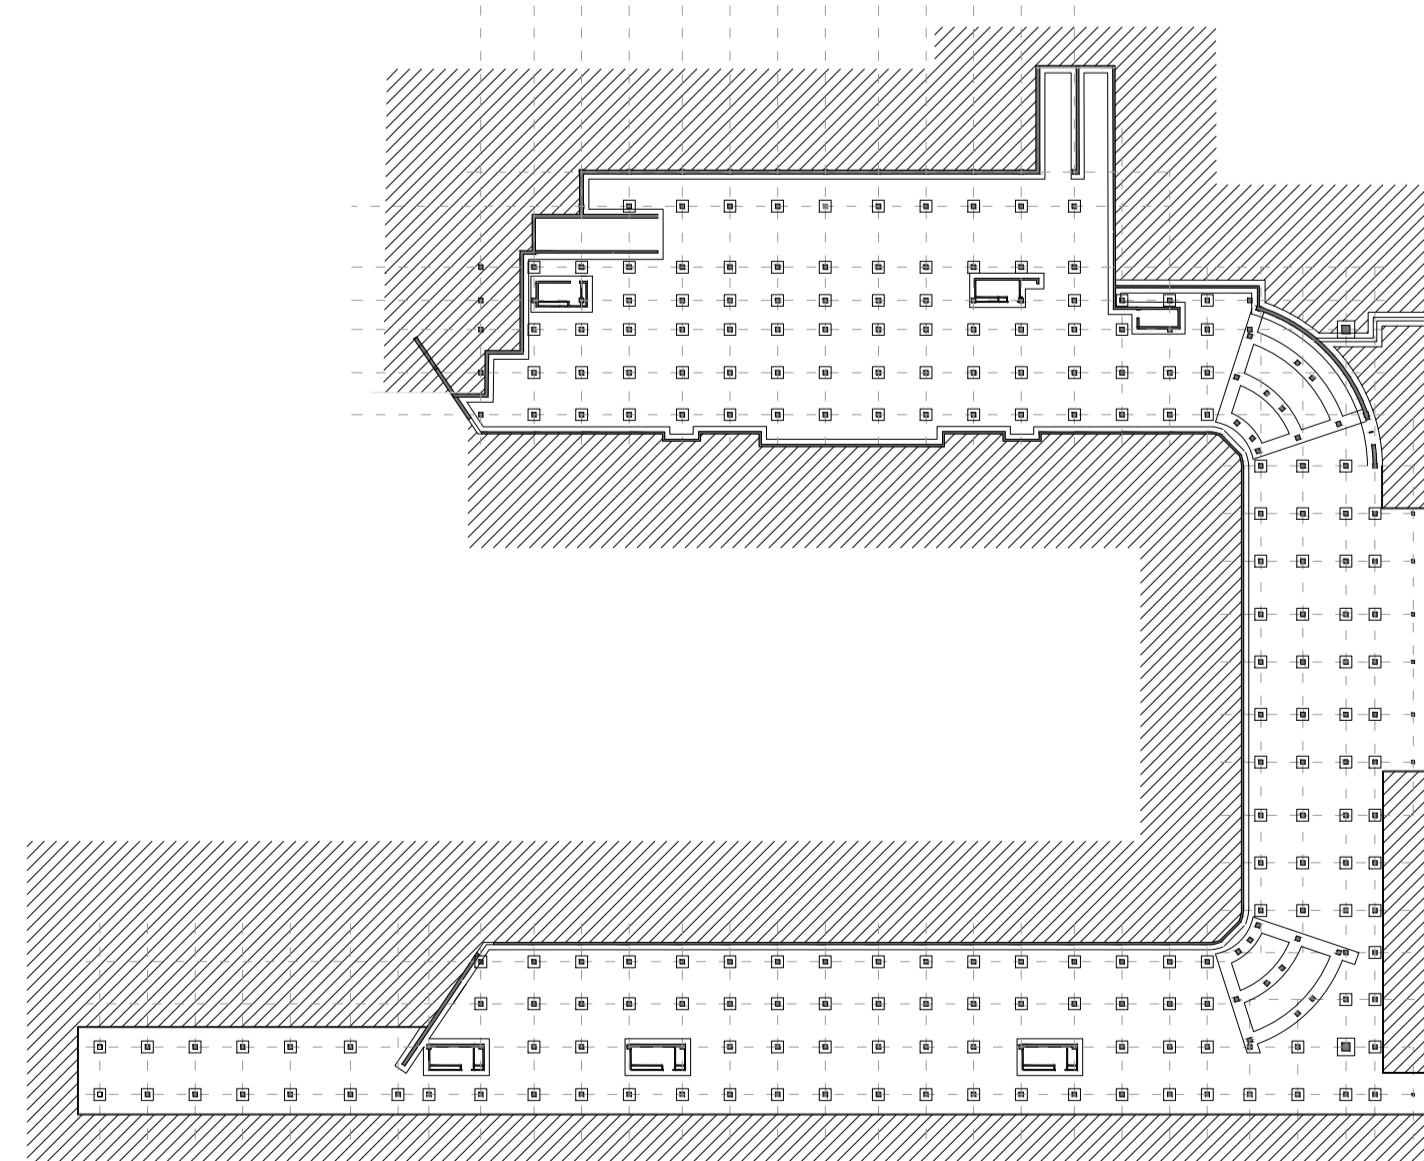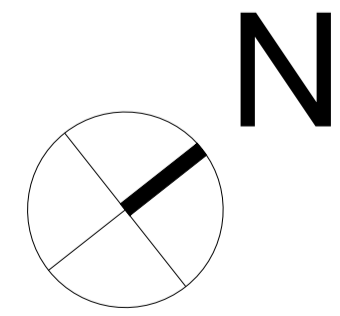

SCHEMA STRUTTURALE

